



SUGARLOAF COMMUNICATIONS TOWER SITE


250 CONESTOGA DRIVE - CARSON CITY, NEVADA

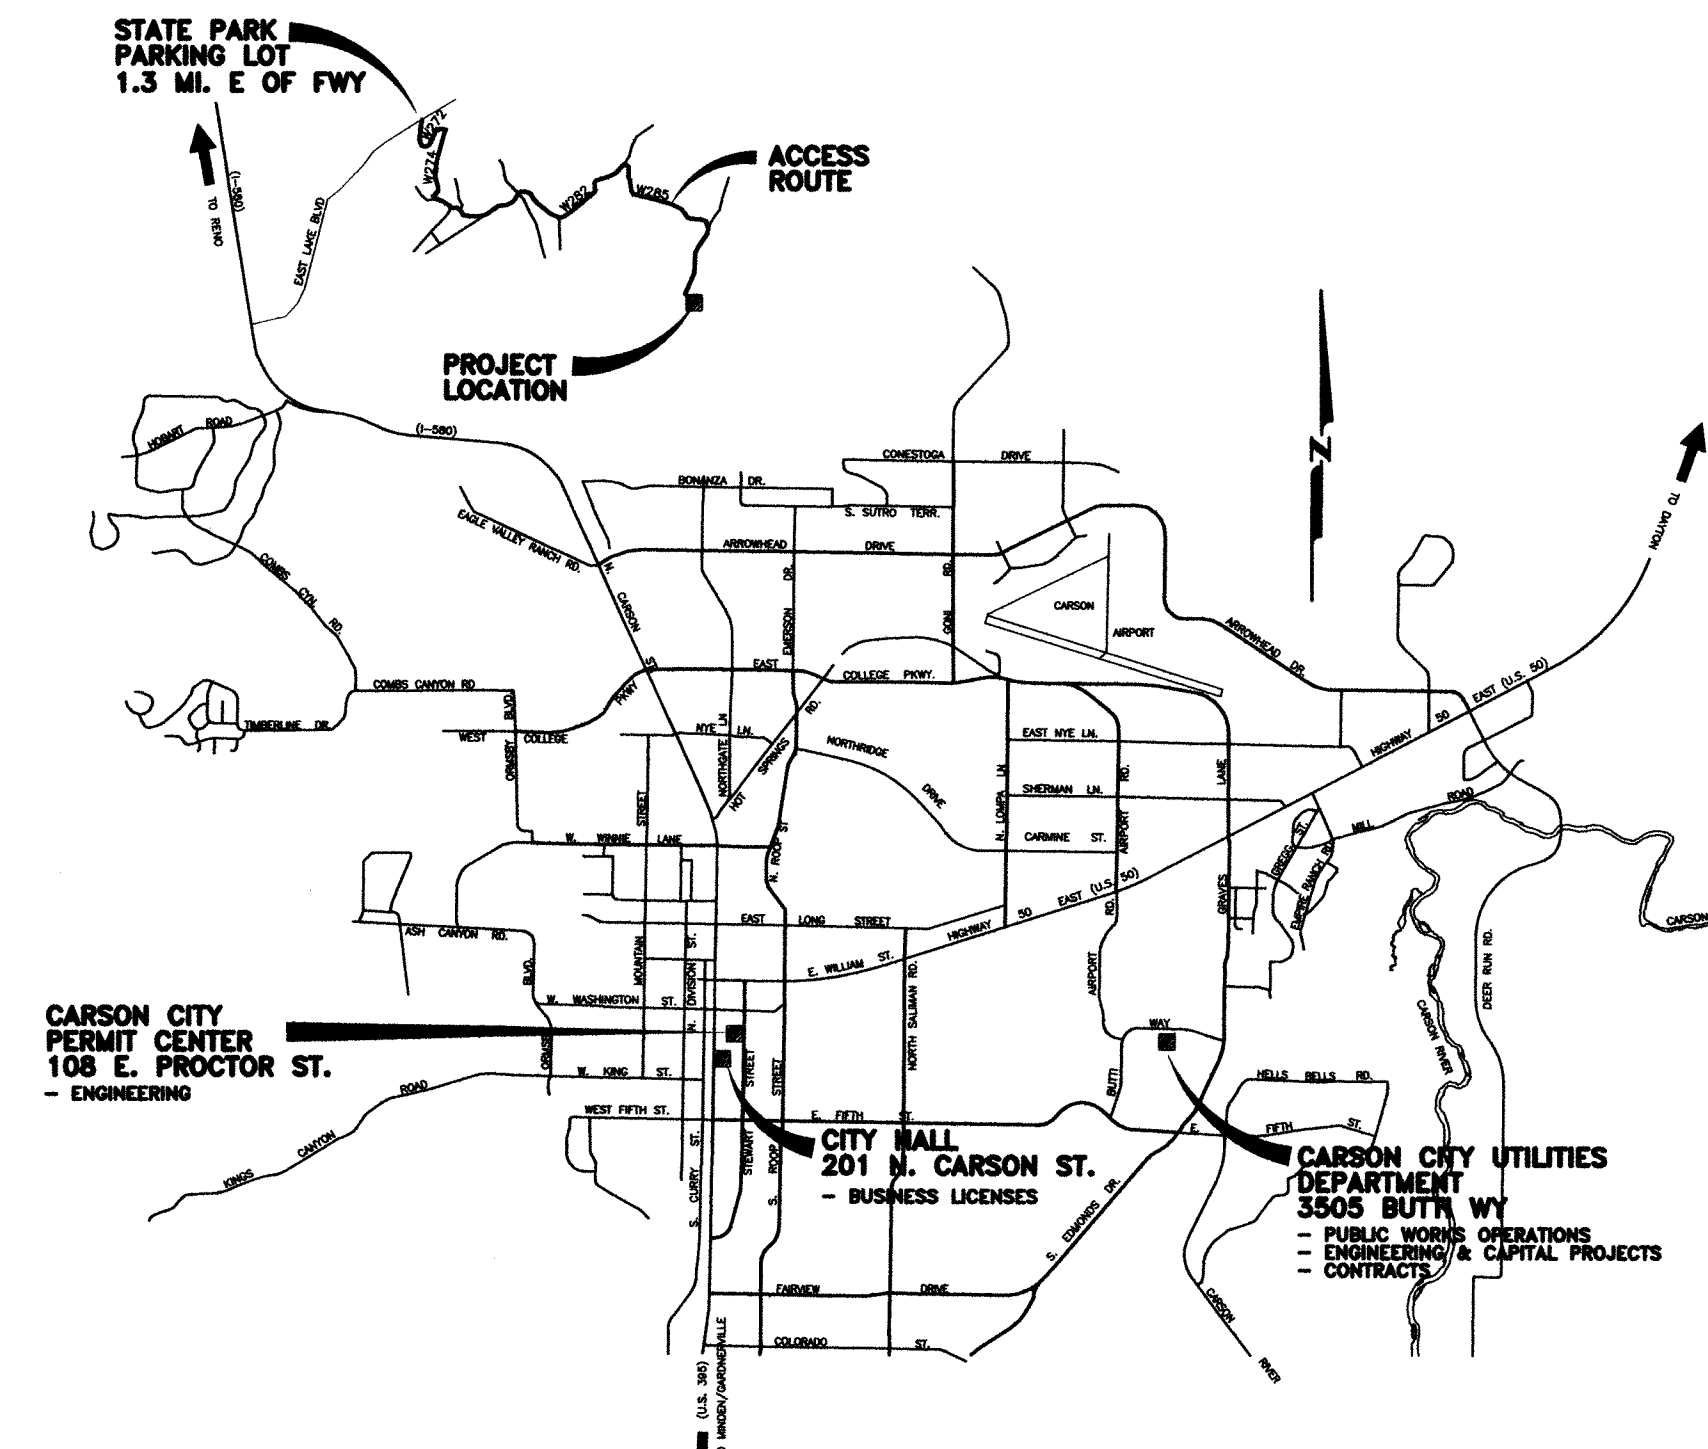


VICINITY MAP
NOT TO SCALE

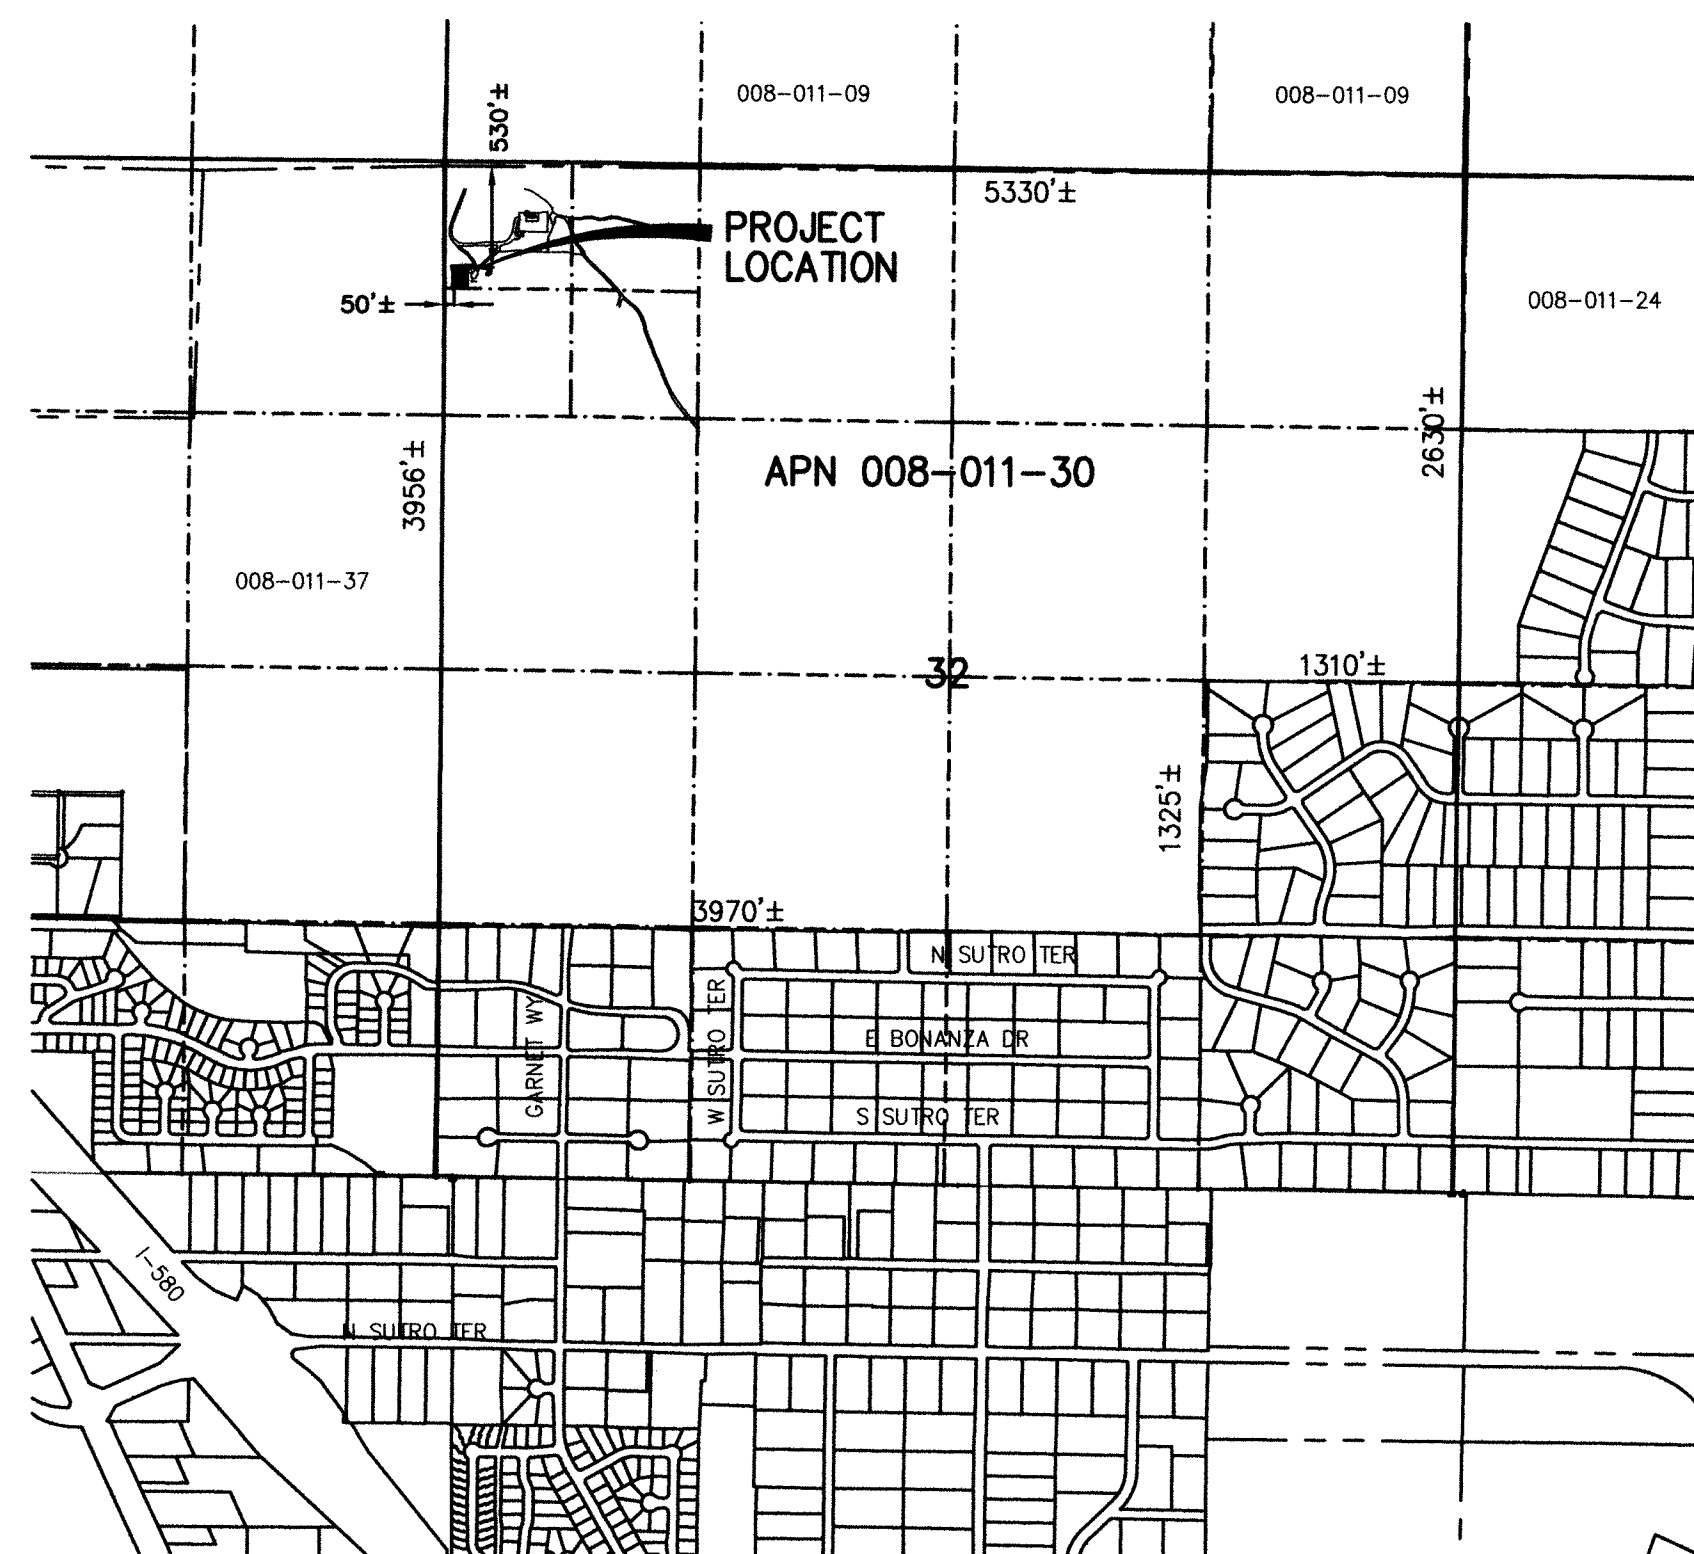

PROJECT LOCATION
NOT TO SCALE

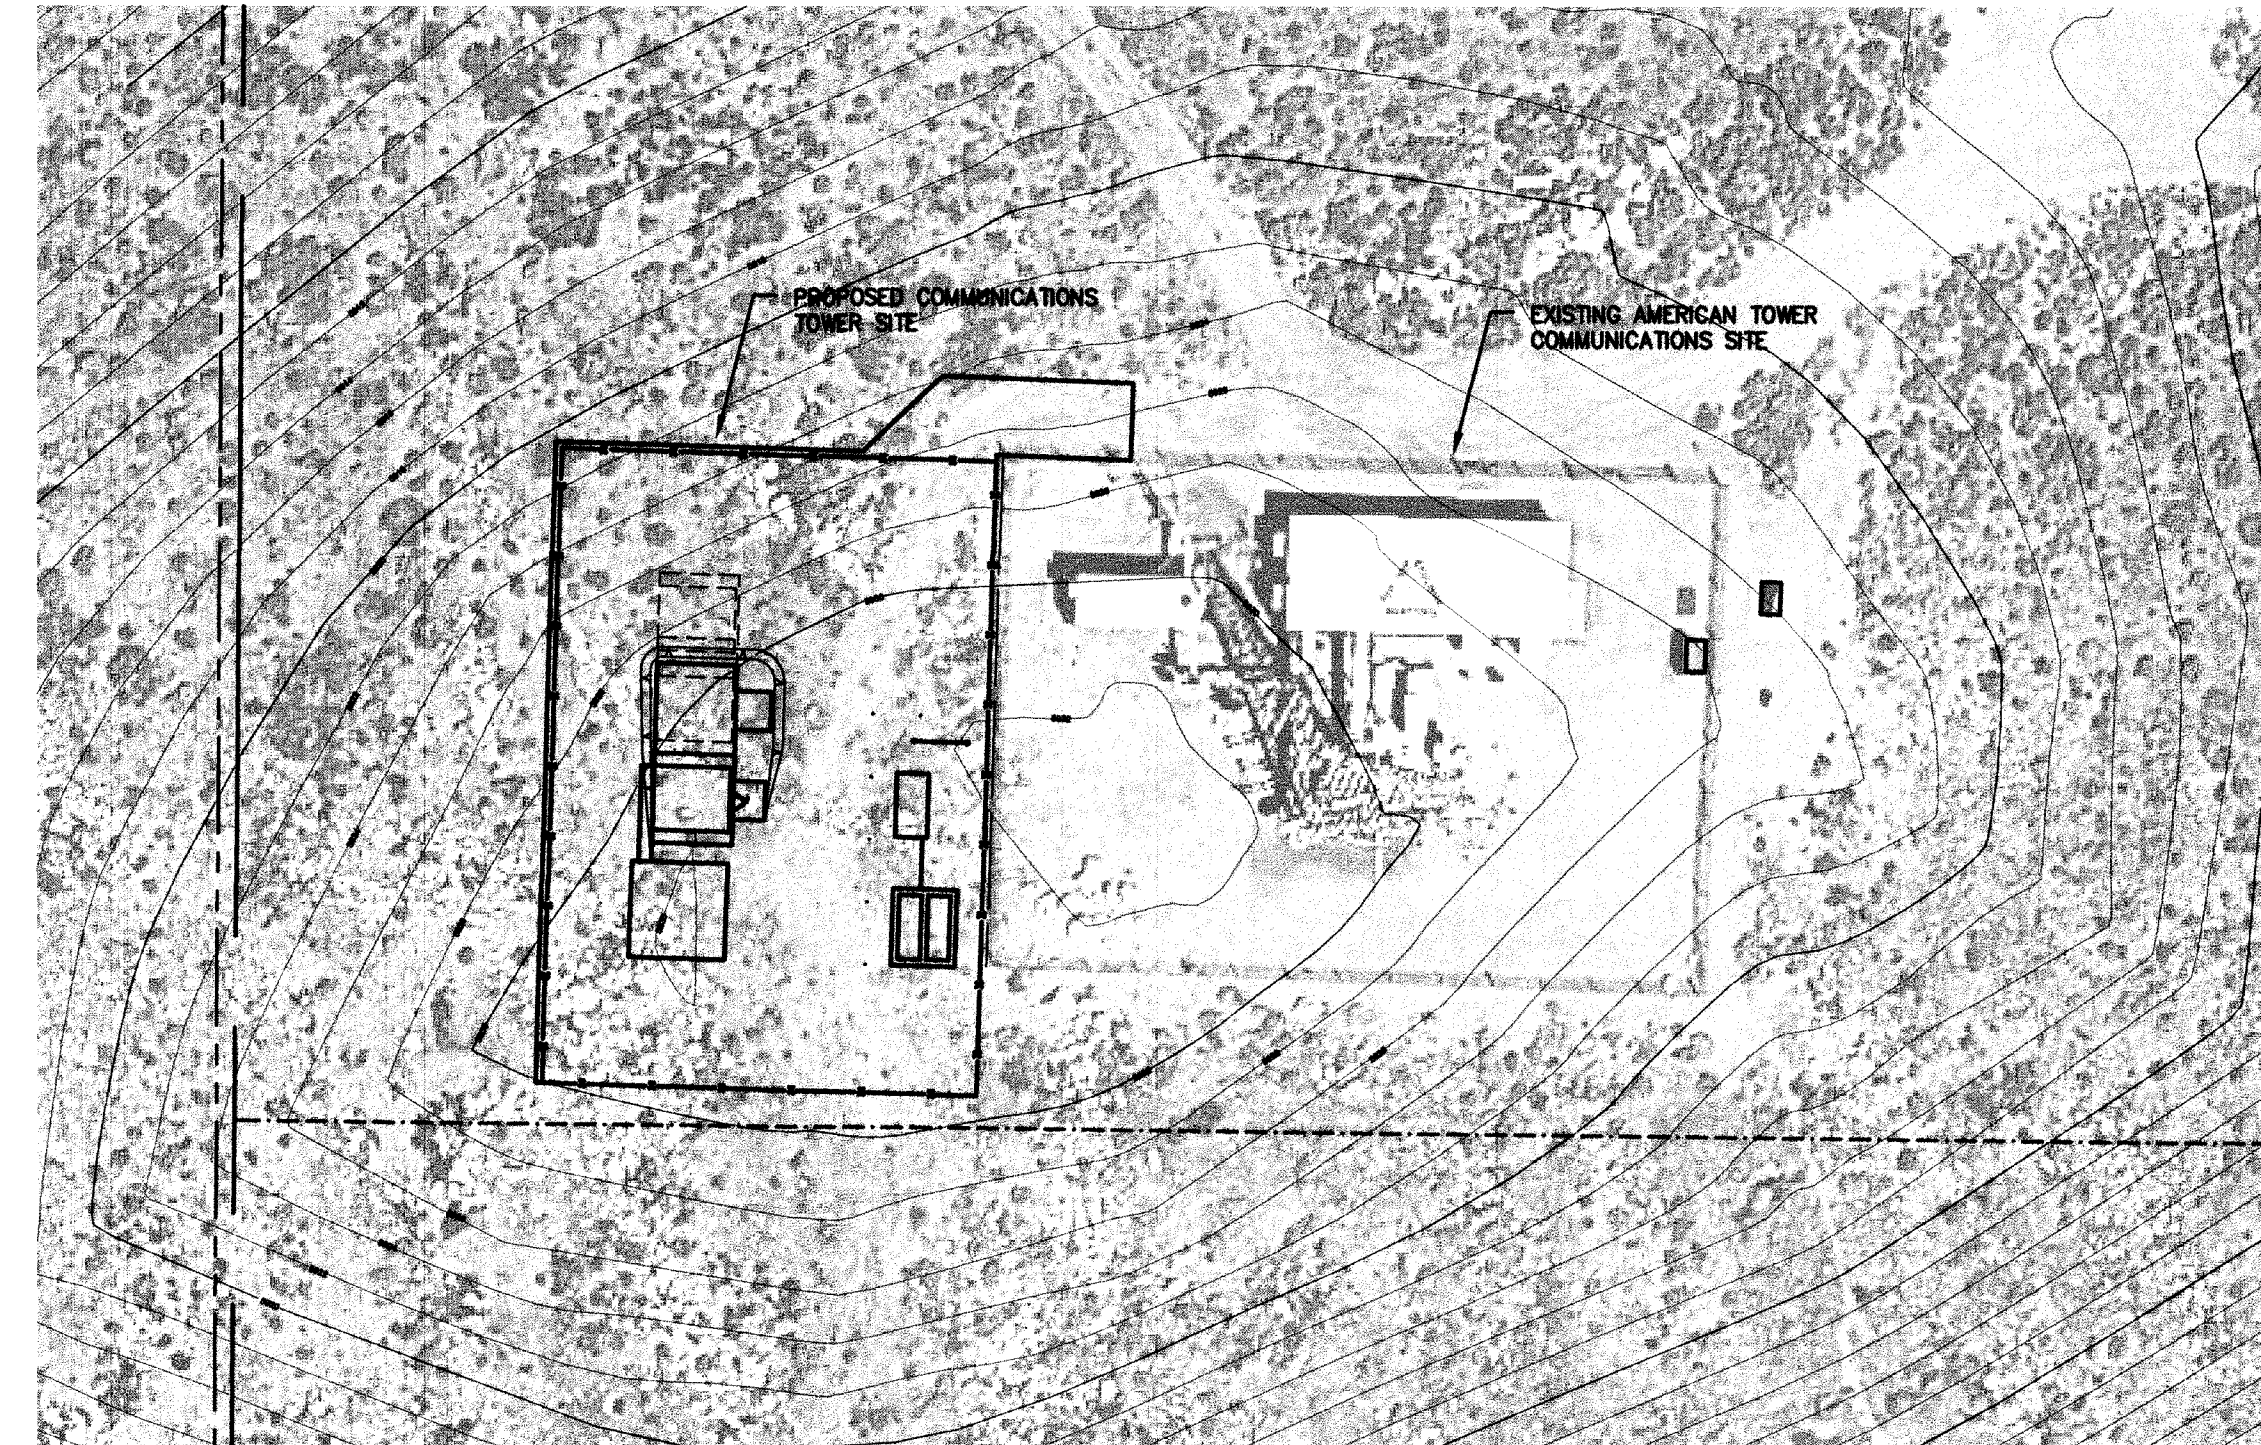

PROPOSED SITE
SCALE: 1" = 30'

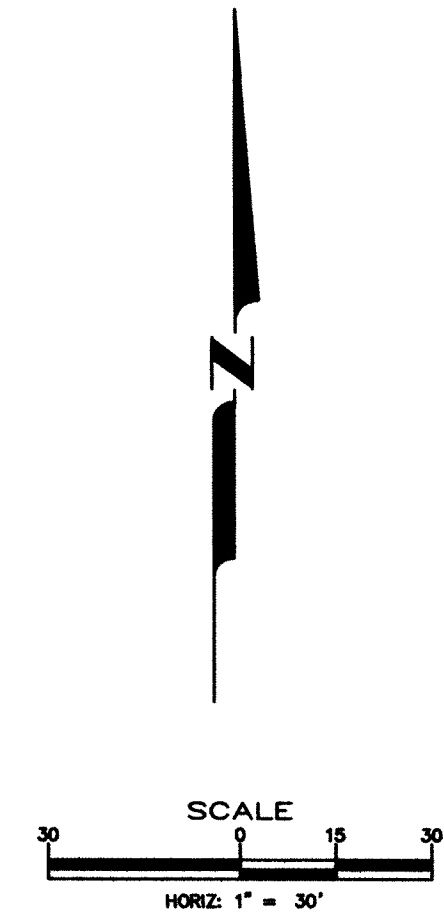

APPLICANT:

CARSON CITY PUBLIC WORKS DEPT.
OPERATIONS DIVISION
3505 BUTTI WAY
CARSON CITY, NV 89701
DARREN ANDERSON (775) 283-7584

OWNER:

USA / BLM
LEASE HOLDER : CARSON CITY

REQUEST:

COMMUNICATIONS SITE FOR CONSTRUCTION
OF NEW COMMUNICATIONS TOWER

PARCEL NUMBER:

008-011-30

ZONING:

PR - PUBLIC REGIONAL

LOCATION:

250 CONESTOGA DR.
N/W 1/4 OF THE NW 1/4 OF SEC. 32
T 16 R 20 M.D.B. & M.


SHEET INDEX:

C1	TITLE SHEET
C2	SITE PLAN
C3	GRADING PLAN
C4	DETAILS
C5	TOWER DETAILS
E1	ELECTRICAL TITLE SHEET
E2	ELECTRICAL SINGLE LINE & ELEVATIONS
E3	UTILITY & GROUNDING PLAN
E4	ELECTRICAL DETAILS

DESIGNED BY: DA
DRAWN BY: BD
CHECKED BY: TG
DWG NO.: 3-1304851-C3D
SCALE (HORIZ): AS SHOWN
SCALE (VERT):
PLOT DATE: 2014APR22

CARSON CITY
PUBLIC WORKS DEPARTMENT

3505 BUTTI WAY CARSON CITY, NEVADA 89701
PH: 887-2355 FAX: 887-2112

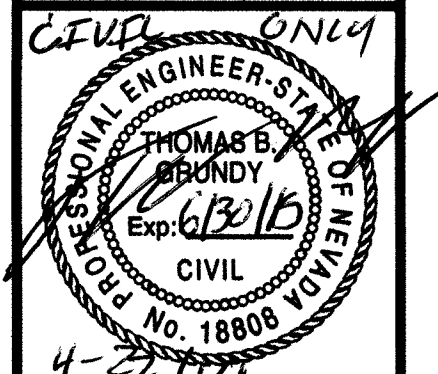

BY APP'D

DESCRIPTION

REV. DATE


SUGARLOAF COMMUNICATIONS
TOWER SITE

TITLE SHEET

SHEET
C1
OF
9

APPLICATION NO. _____

1. RADIO TOWER:
CONTRACTOR TO ENGINEER, DELIVER AND INSTALL AN ANSI/ITA-222 REV G. CLASS III 80' LATTICE TOWER, INCLUDING FOUNDATION, WITH CLIMBER FACILITIES AND FALL ARREST SYSTEM IN ACCORDANCE WITH ANSI/ASSE Z359 STANDARD. THE TOWER MUST BE ABLE TO SUPPORT ALL EQUIPMENT SHOWN ON SHEET CS INCLUDING FUTURE EQUIPMENT.
2. ALL CONCRETE:
UNLESS OTHERWISE NOTED PORTLAND CEMENT CONCRETE (PCC) SHALL HAVE THE FOLLOWING CHARACTERISTICS: MASTERFIBER MAC MATRIX MACRO FIBERS OR APPROVED ALKAL (AT A MINIMUM OF 3 POUNDS PER CUBIC YARD), 4000 PSI MINIMUM COMPRESSIVE STRENGTH AT 28 DAYS, MINIMUM 6 SACKS OF CEMENT PER CUBIC YARD, W/MAXIMUM WATER-CEMENT RATIO OF 0.45, AIR ENTRAINMENT 6% +/-1.5%, SLUMP 1-4 INCHES. ALL MATERIALS SHALL CONFORM TO SECTION 202 OF THE STANDARD SPECIFICATIONS FOR PUBLIC WORKS REQUIREMENTS FOR CONCRETE EXPOSED TO FREEZE THAW ENVIRONMENTS. ALL SLABS TO BE 6" PCC ON 6" BASE COMPACTED TO 85% UNLESS OTHERWISE NOTED.
3. PROPANE TANKS AND GENERATOR TO BE ANCHORED TO SLABS WITH 4"-1/2" ANCHOR BOLTS AND 3"x 3" PLATE WASHERS. BUILDING AND POWER PEDESTALS TO BE ANCHORED AS SHOWN ON ELEVATIONS THIS SHEET.
4. ICE BRIDGE SHALL BE 24" WIDE, HOT DIP GALVANIZED, SOLID BRIDGE W/ TRIPLE TRAPEZIE KITS. ICE BRIDGE SHALL BE GROUNDED WITH AN EXOTHERMIC WELD.
5. CONTRACTOR TO CLEAR SITE OF LOOSE ROCKS AND VEGETATION TO ALLOW VEHICLE ACCESS AROUND THE SITE. CONTRACTOR TO RESTORE ANY DISTURBED LAND OUTSIDE OF THE PROJECT SITE TO ITS ORIGINAL CONDITION.
6. CONTRACTOR IS RESPONSIBLE FOR ALL EXCAVATION, SUBGRADE PREPARATION, AND REMOVAL OF EXISTING OBSTRUCTIONS IN ORDER TO INSTALL THE COMMUNICATION SITE FACILITIES.

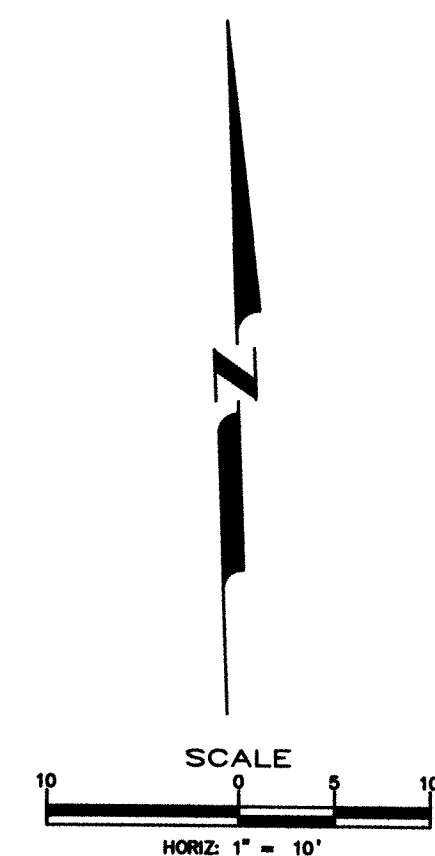

**CARSON CITY
PUBLIC WORKS DEPARTMENT**

3505 BUTTI WAY CARSON CITY, NEVADA 89701
PH: 887-2355 FAX: 887-2112




[illegible]

**SUGARLOAF COMMUNICATIONS
TOWER SITE**


SITE PLAN

SHEET
C2
OF
9

DESIGNED BY: DA
DRAWN BY: BD
CHECKED BY: TG
DWG NO.: DUCKCOMBMS1
SCALE (HORIZ): AS SHOWN
SCALE (VERT):
PLOT DATE: 2014APR22

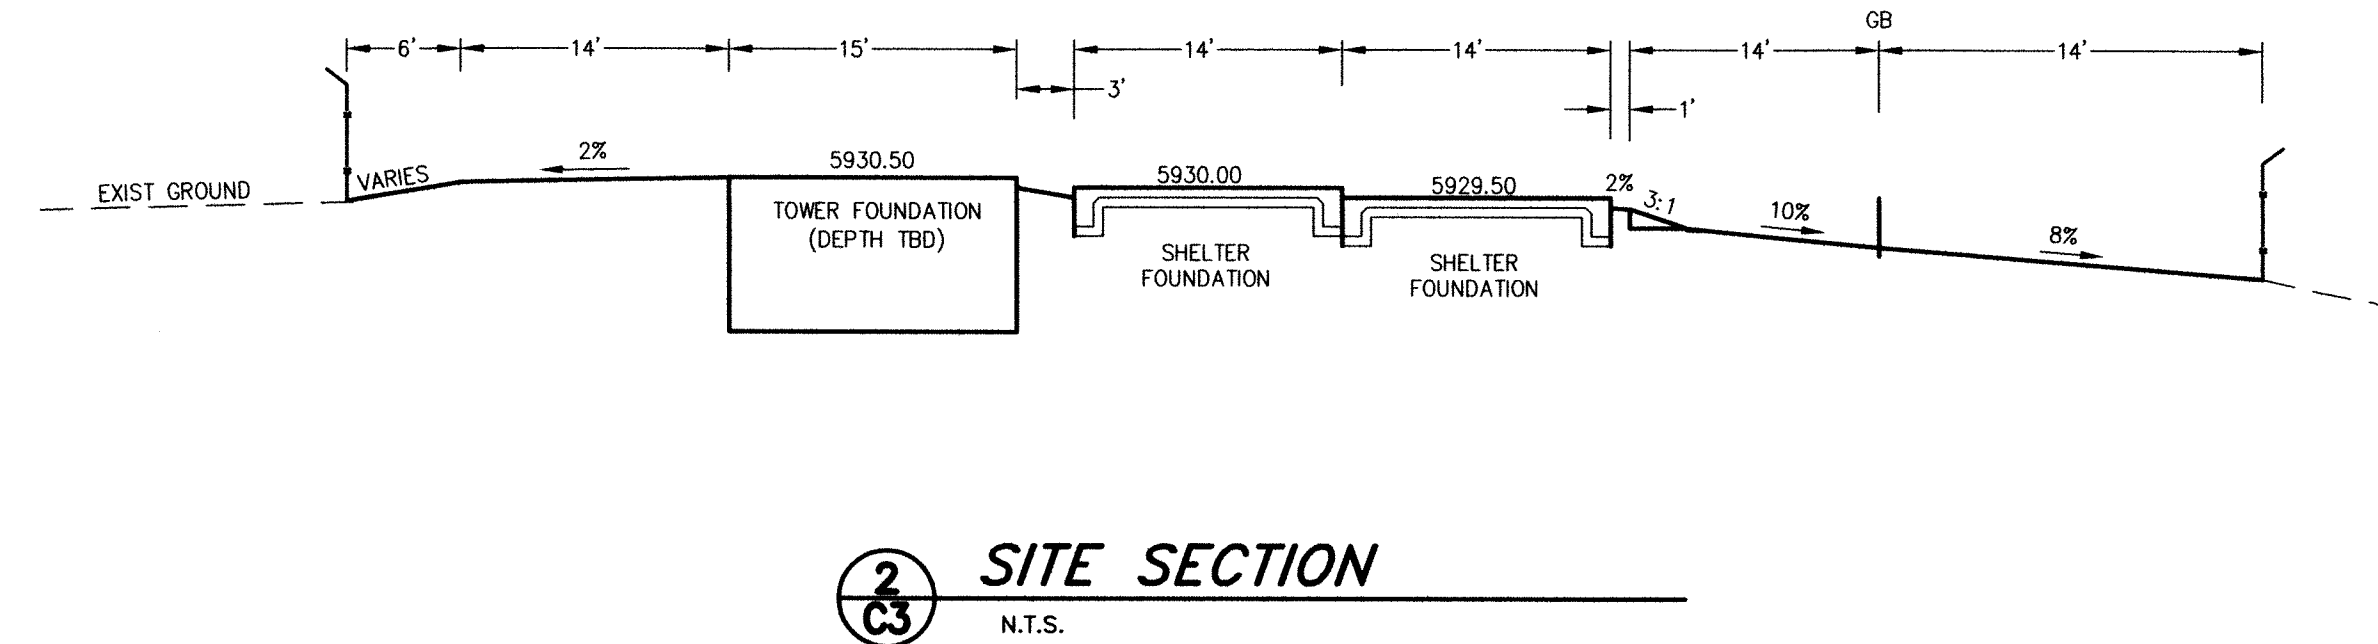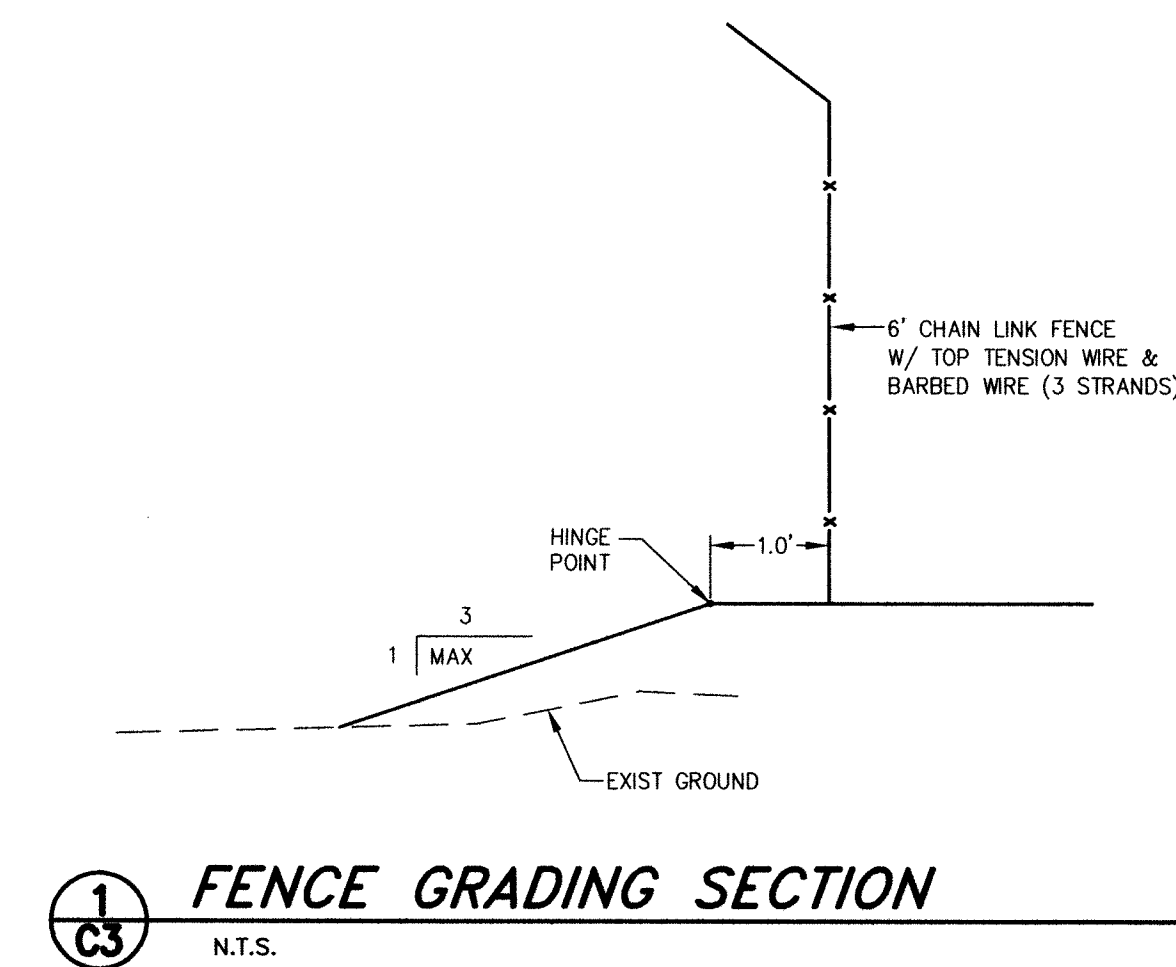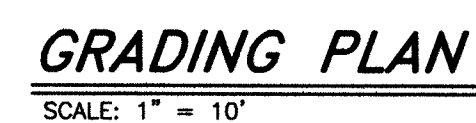

SHEET
C3
— OF —
9

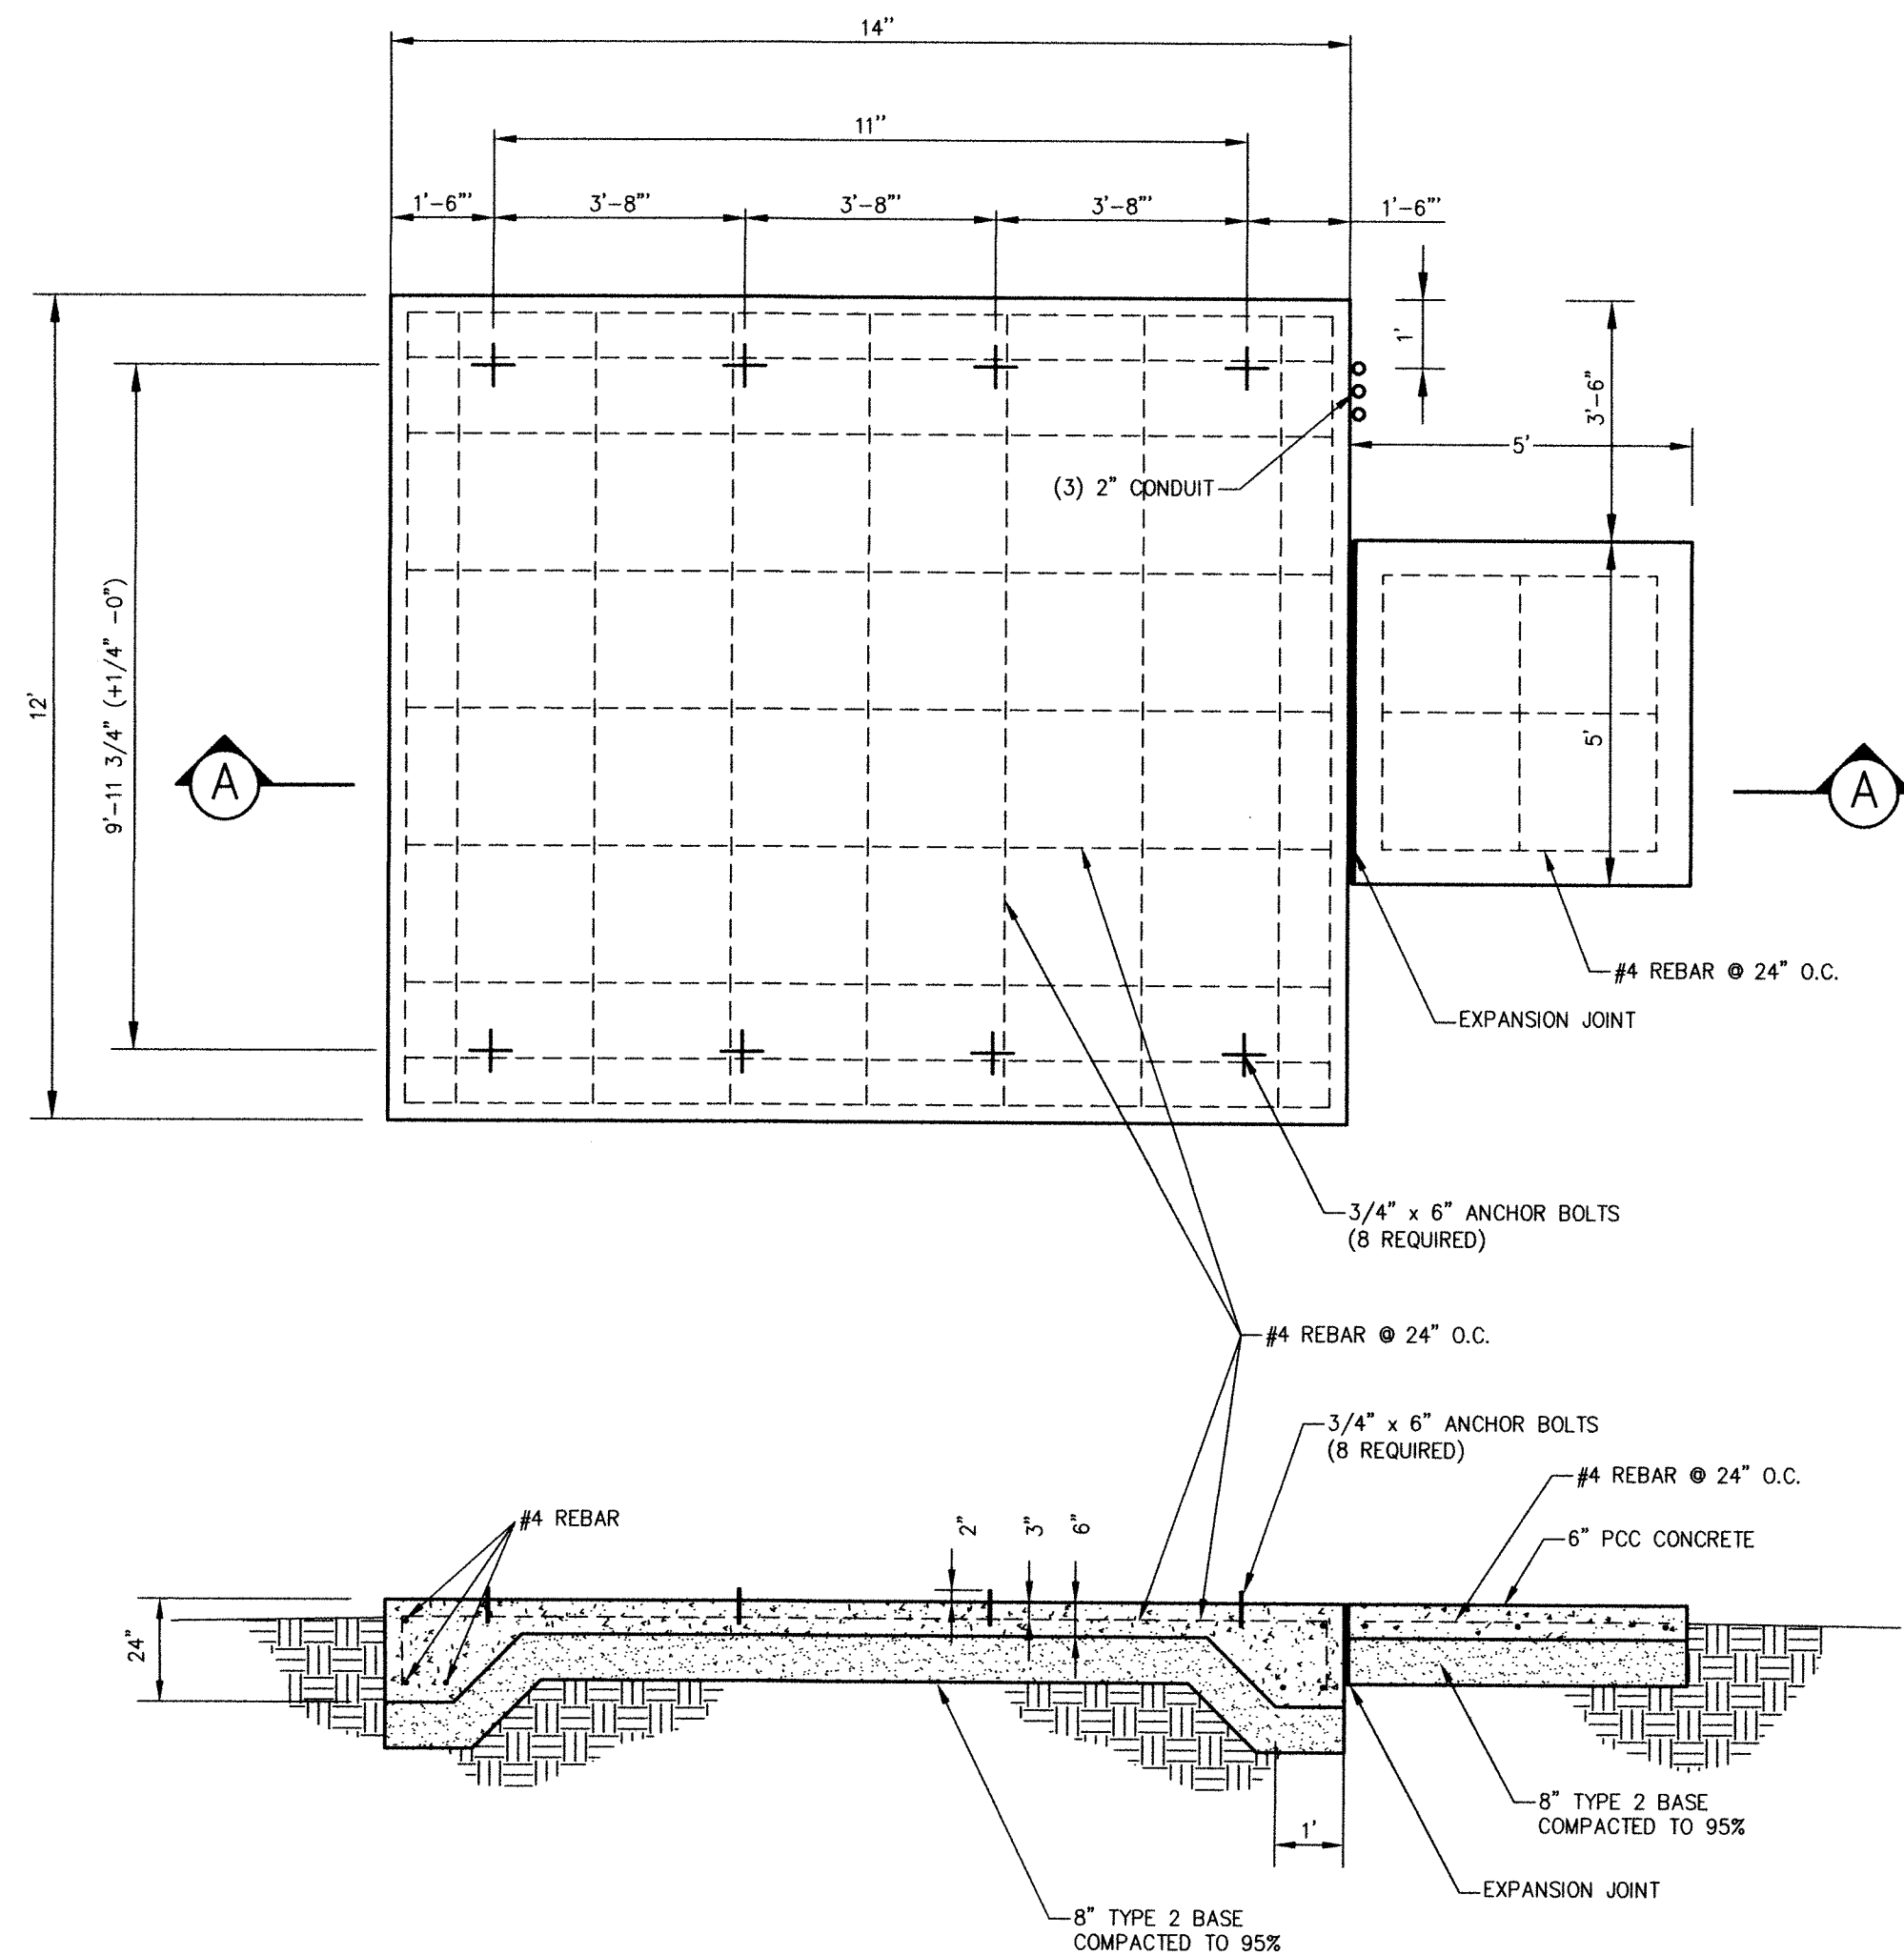


SECTION A-A


NOTES:

- ALL CONCRETE: UNLESS OTHERWISE NOTED PORTLAND CEMENT CONCRETE (PCC) SHALL HAVE THE FOLLOWING CHARACTERISTICS: 4000 PSI MINIMUM COMPRESSIVE STRENGTH AT 28 DAYS, MINIMUM 6 SACKS OF CEMENT PER CUBIC YARD, W/MAXIMUM WATER-CEMENT RATIO OF 0.45, AIR ENTRAINMENT 6%+/-1.5%, SLUMP 1-4 INCHES. ALL MATERIALS SHALL CONFORM TO SECTION 202 OF THE STANDARD SPECIFICATIONS FOR PUBLIC WORKS CONSTRUCTION FOR CONCRETE EXPOSED TO FREEZE THAW ENVIRONMENTS. ALL SLABS TO BE 6" PCC ON 6" BASE COMPACTED TO 95% UNLESS OTHERWISE NOTED.
- ALL REBAR TO BE PLACED 3" OFF SOIL AND HAVE A MINIMUM OF 2" CONCRETE COVER.

1 FOUNDATION DETAIL
SCALE: 3/8" = 1'-0"

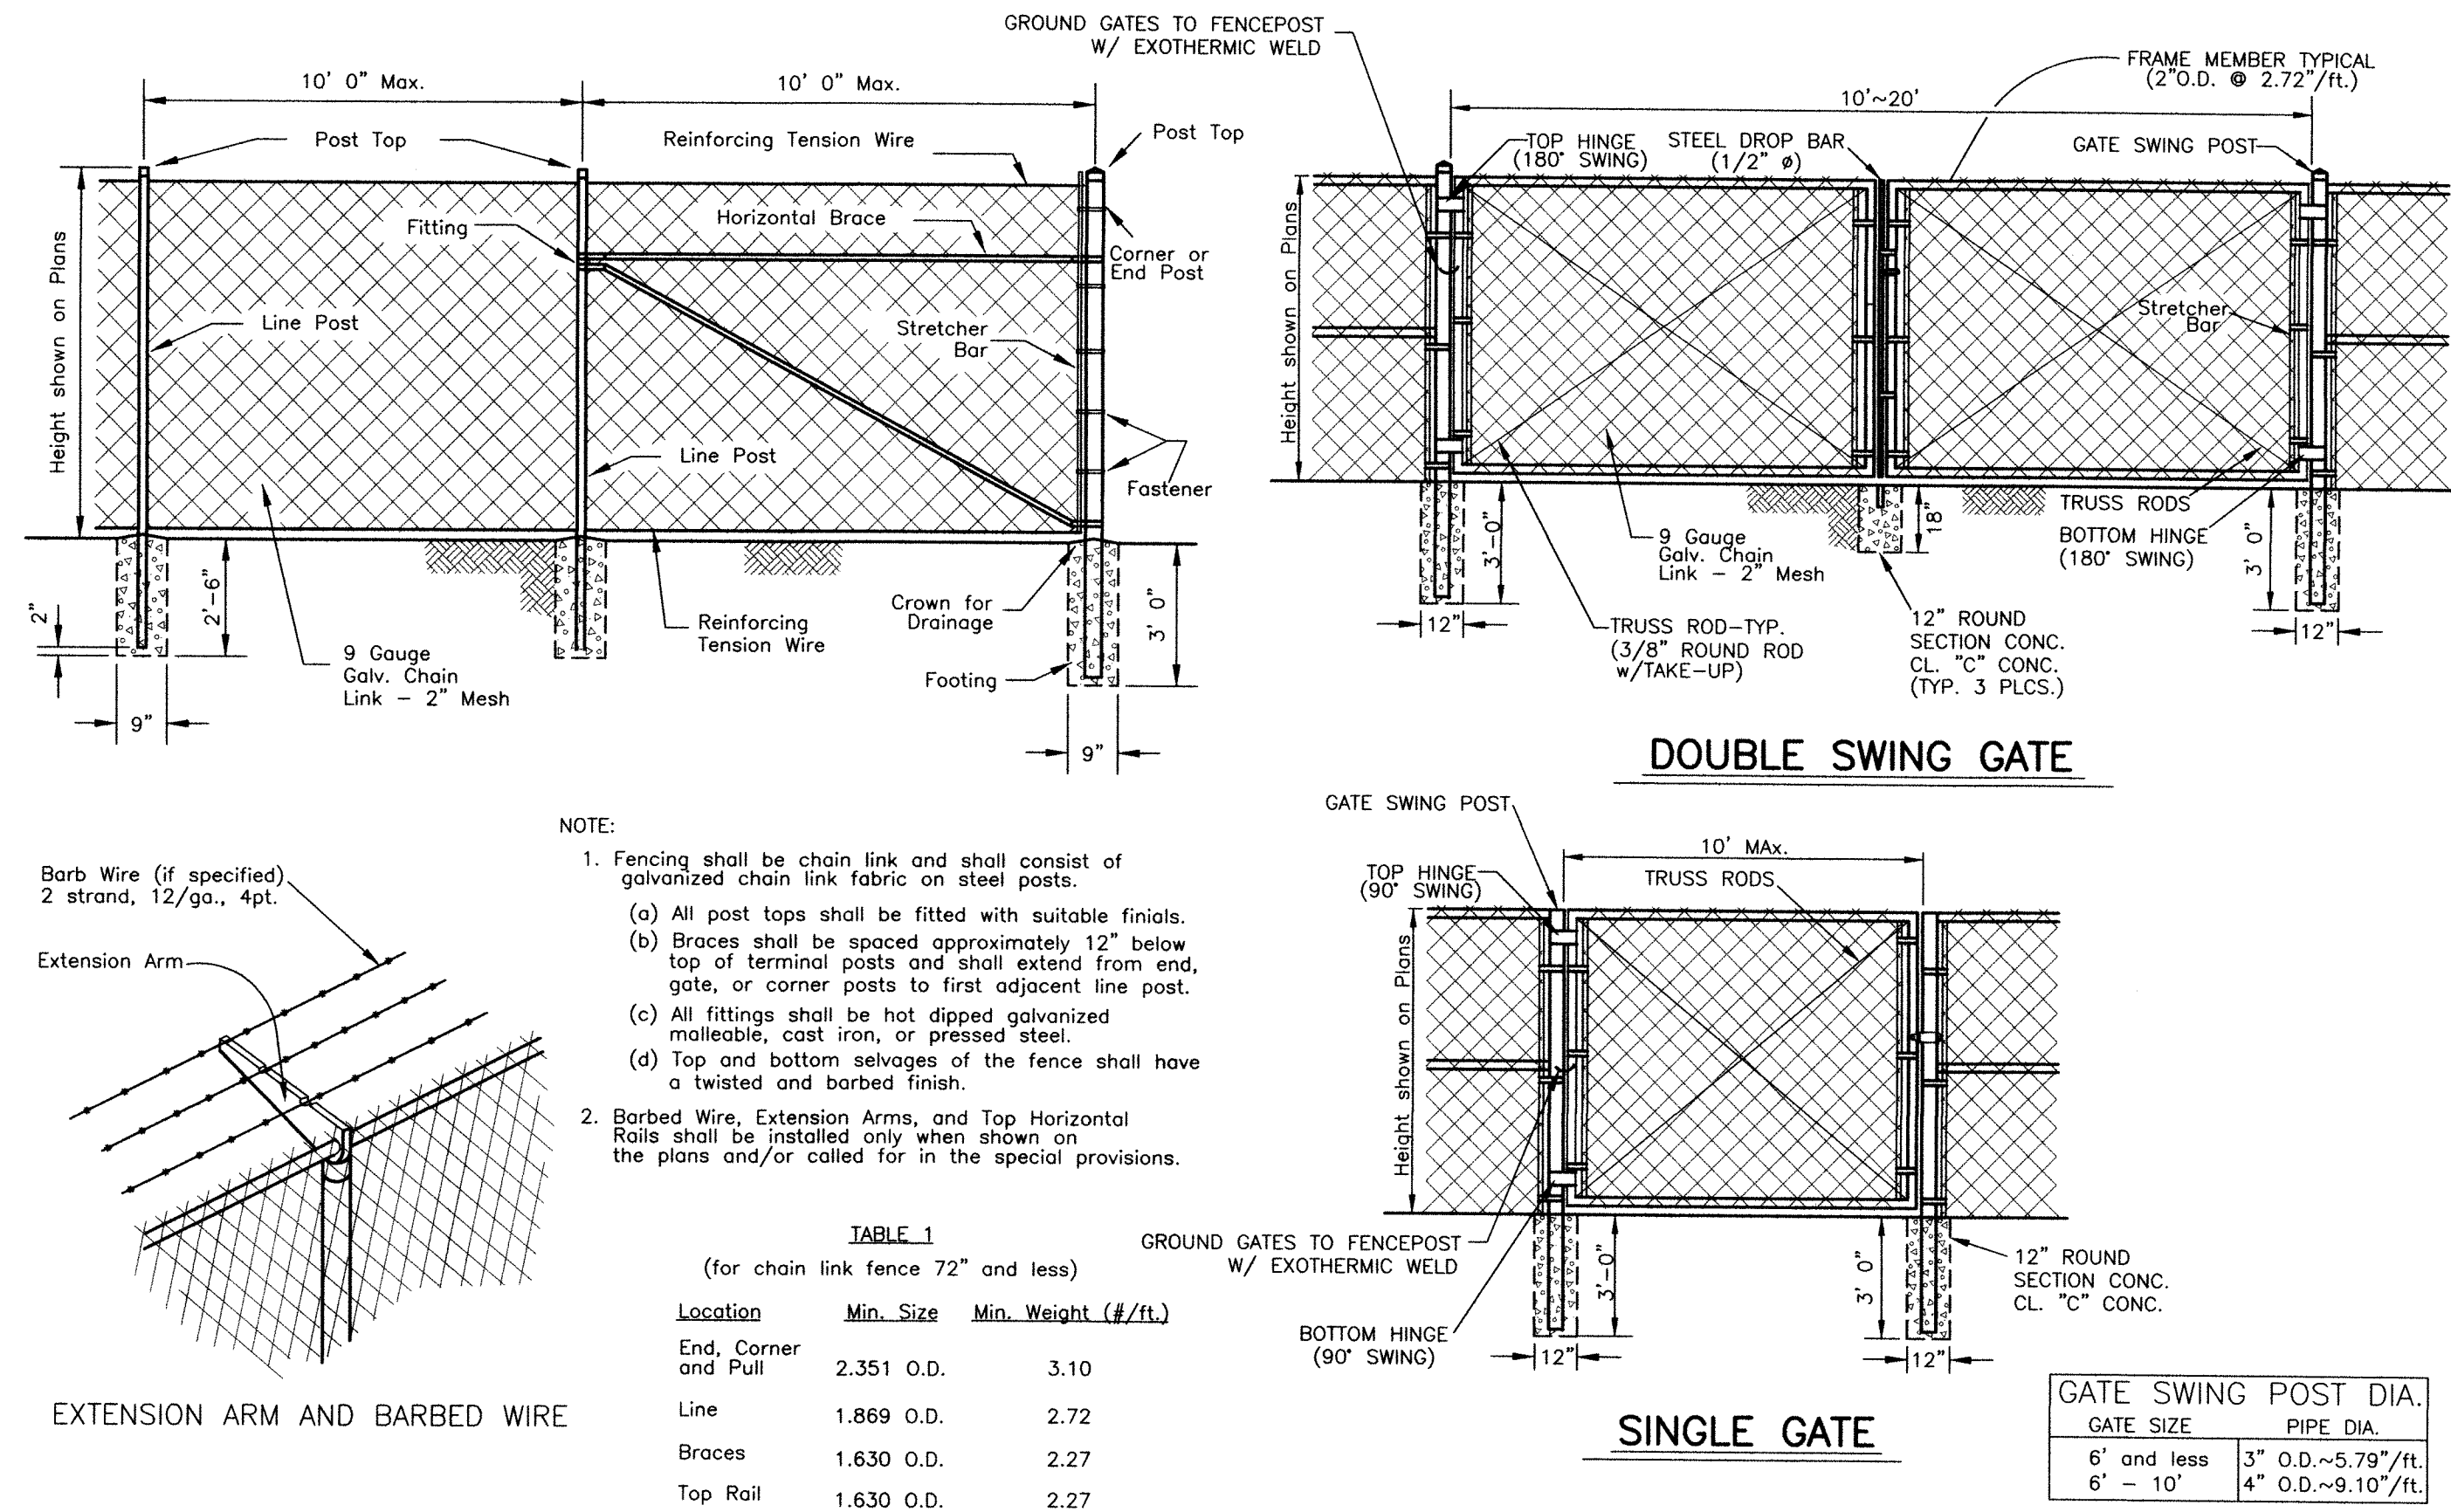

2 CHAIN LINK FENCE DETAIL
N.T.S.

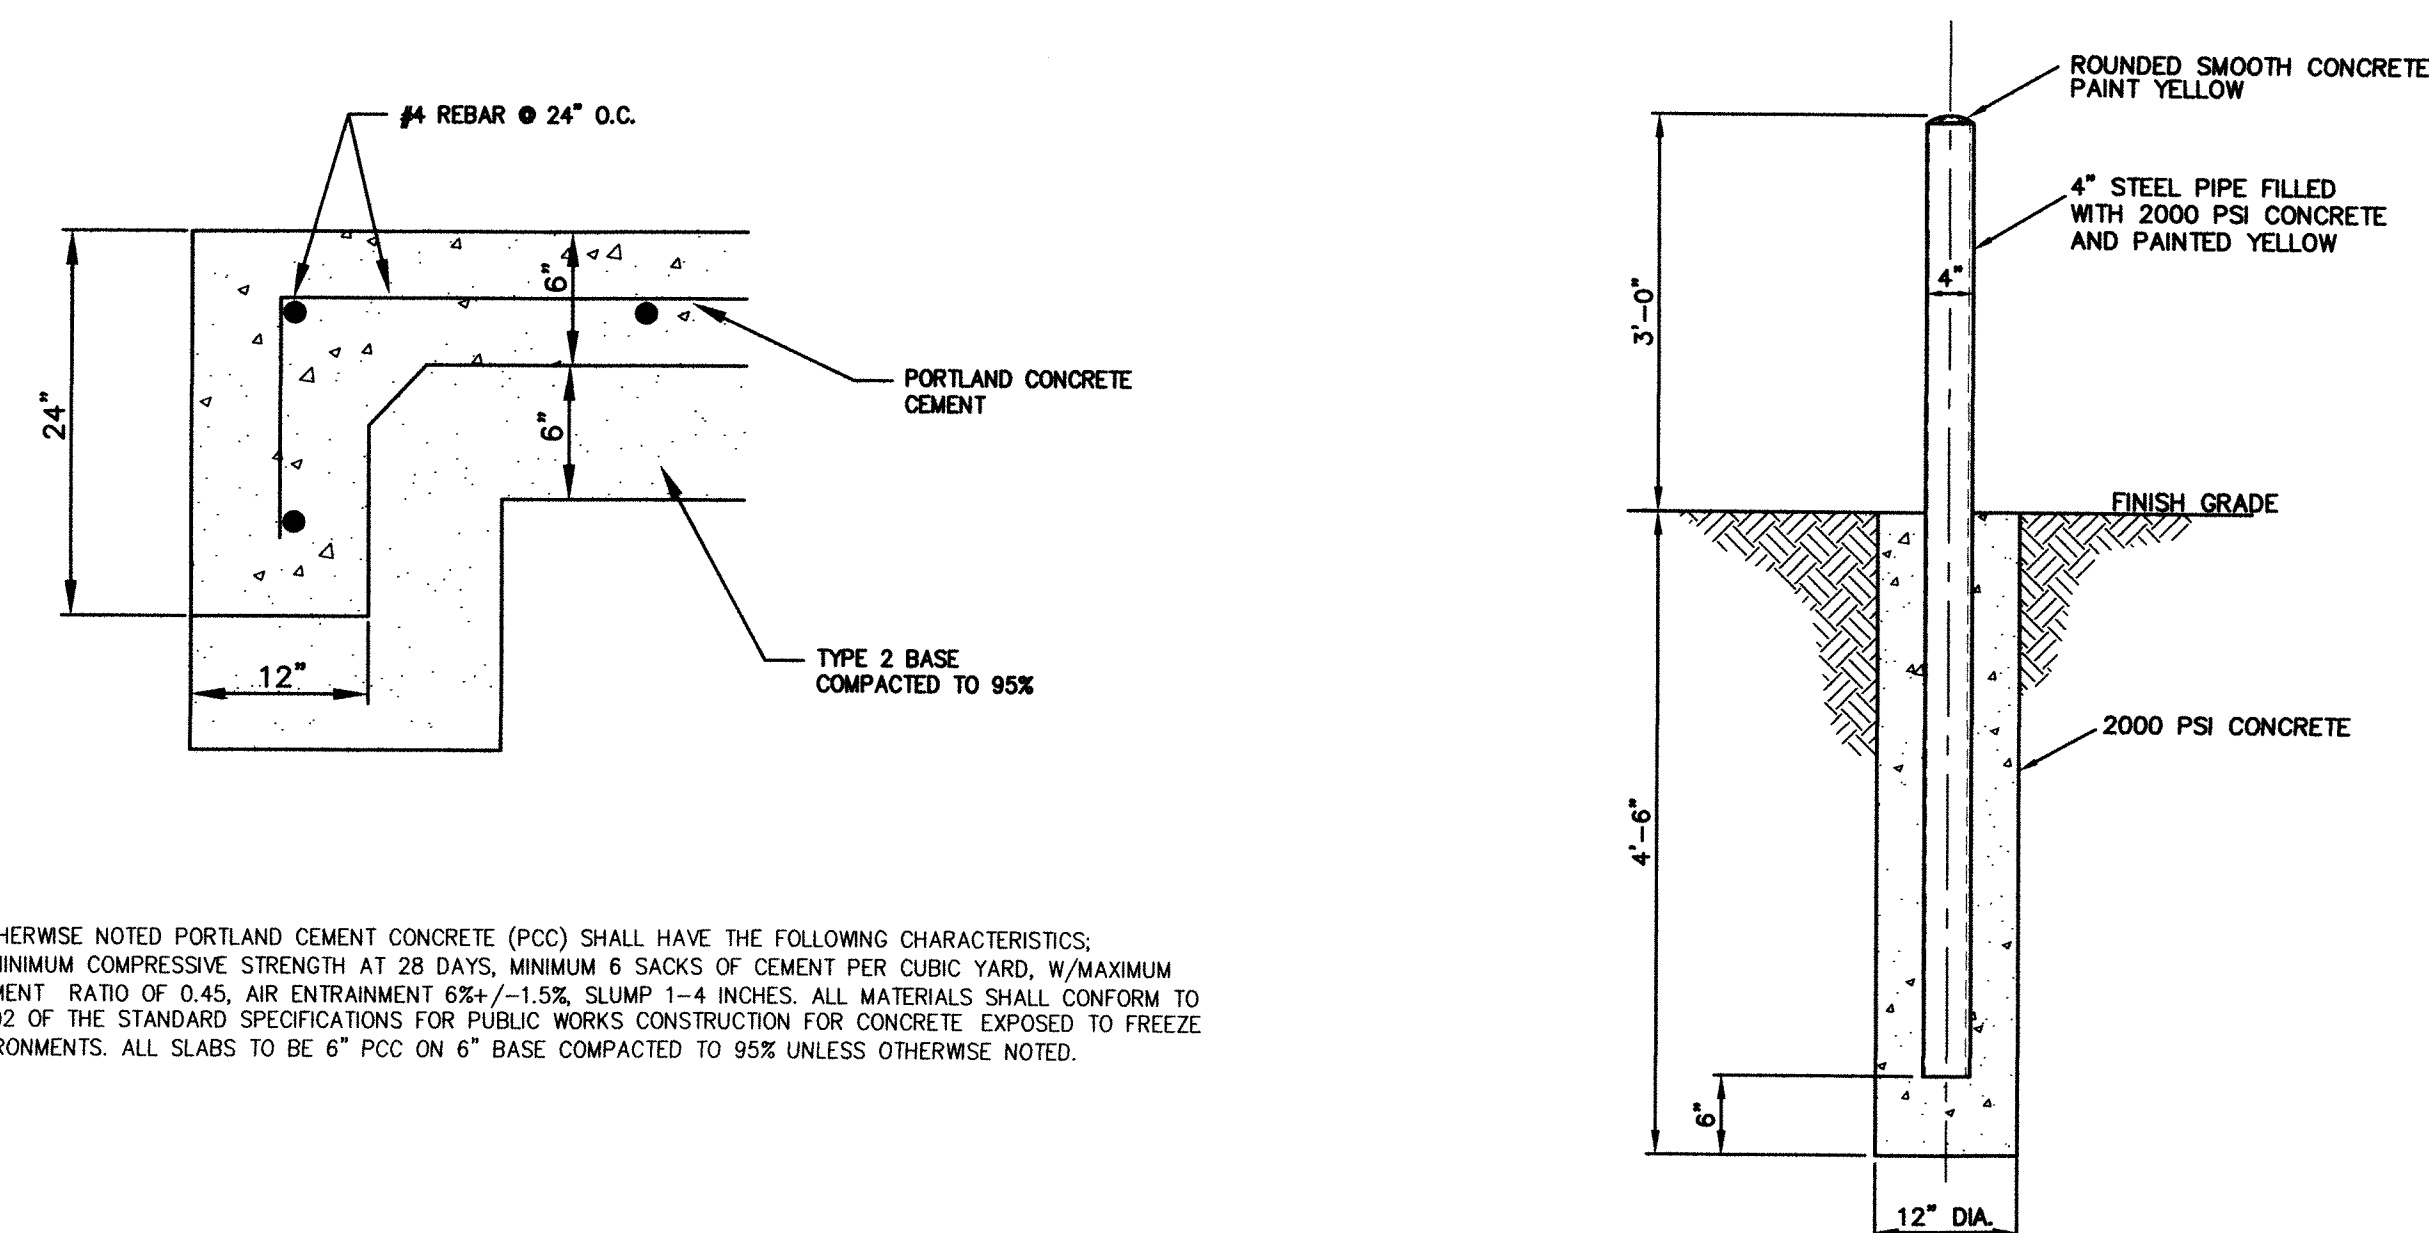

3 PROPANE TANK AND GENERATOR FOUNDATION DETAIL
N.T.S.

4 PIPE BOLLARD DETAIL
N.T.S.

DESIGNED BY: DA
DRAWN BY: BD
CHECKED BY: TG
DWG NO.: DUCKCOMBES1
SCALE (HORIZ): AS SHOWN
SCALE (VERT): AS SHOWN
PLOT DATE: 2014APR22

CARSON CITY
PUBLIC WORKS DEPARTMENT
3505 BUTTI WAY CARSON CITY, NEVADA 89701
PH: 887-2355 FAX: 887-2112

CELESTINE ENGINEER-ONLY
THOMAS B. GRUNDY
Exp. 6/30/15
CIVIL
No. 18808
6/22/14

REV.	DATE	DESCRIPTION	BY	APP'D

SUGARLOAF COMMUNICATIONS
TOWER SITE
DETAILS

SHEET
C4
OF
9